


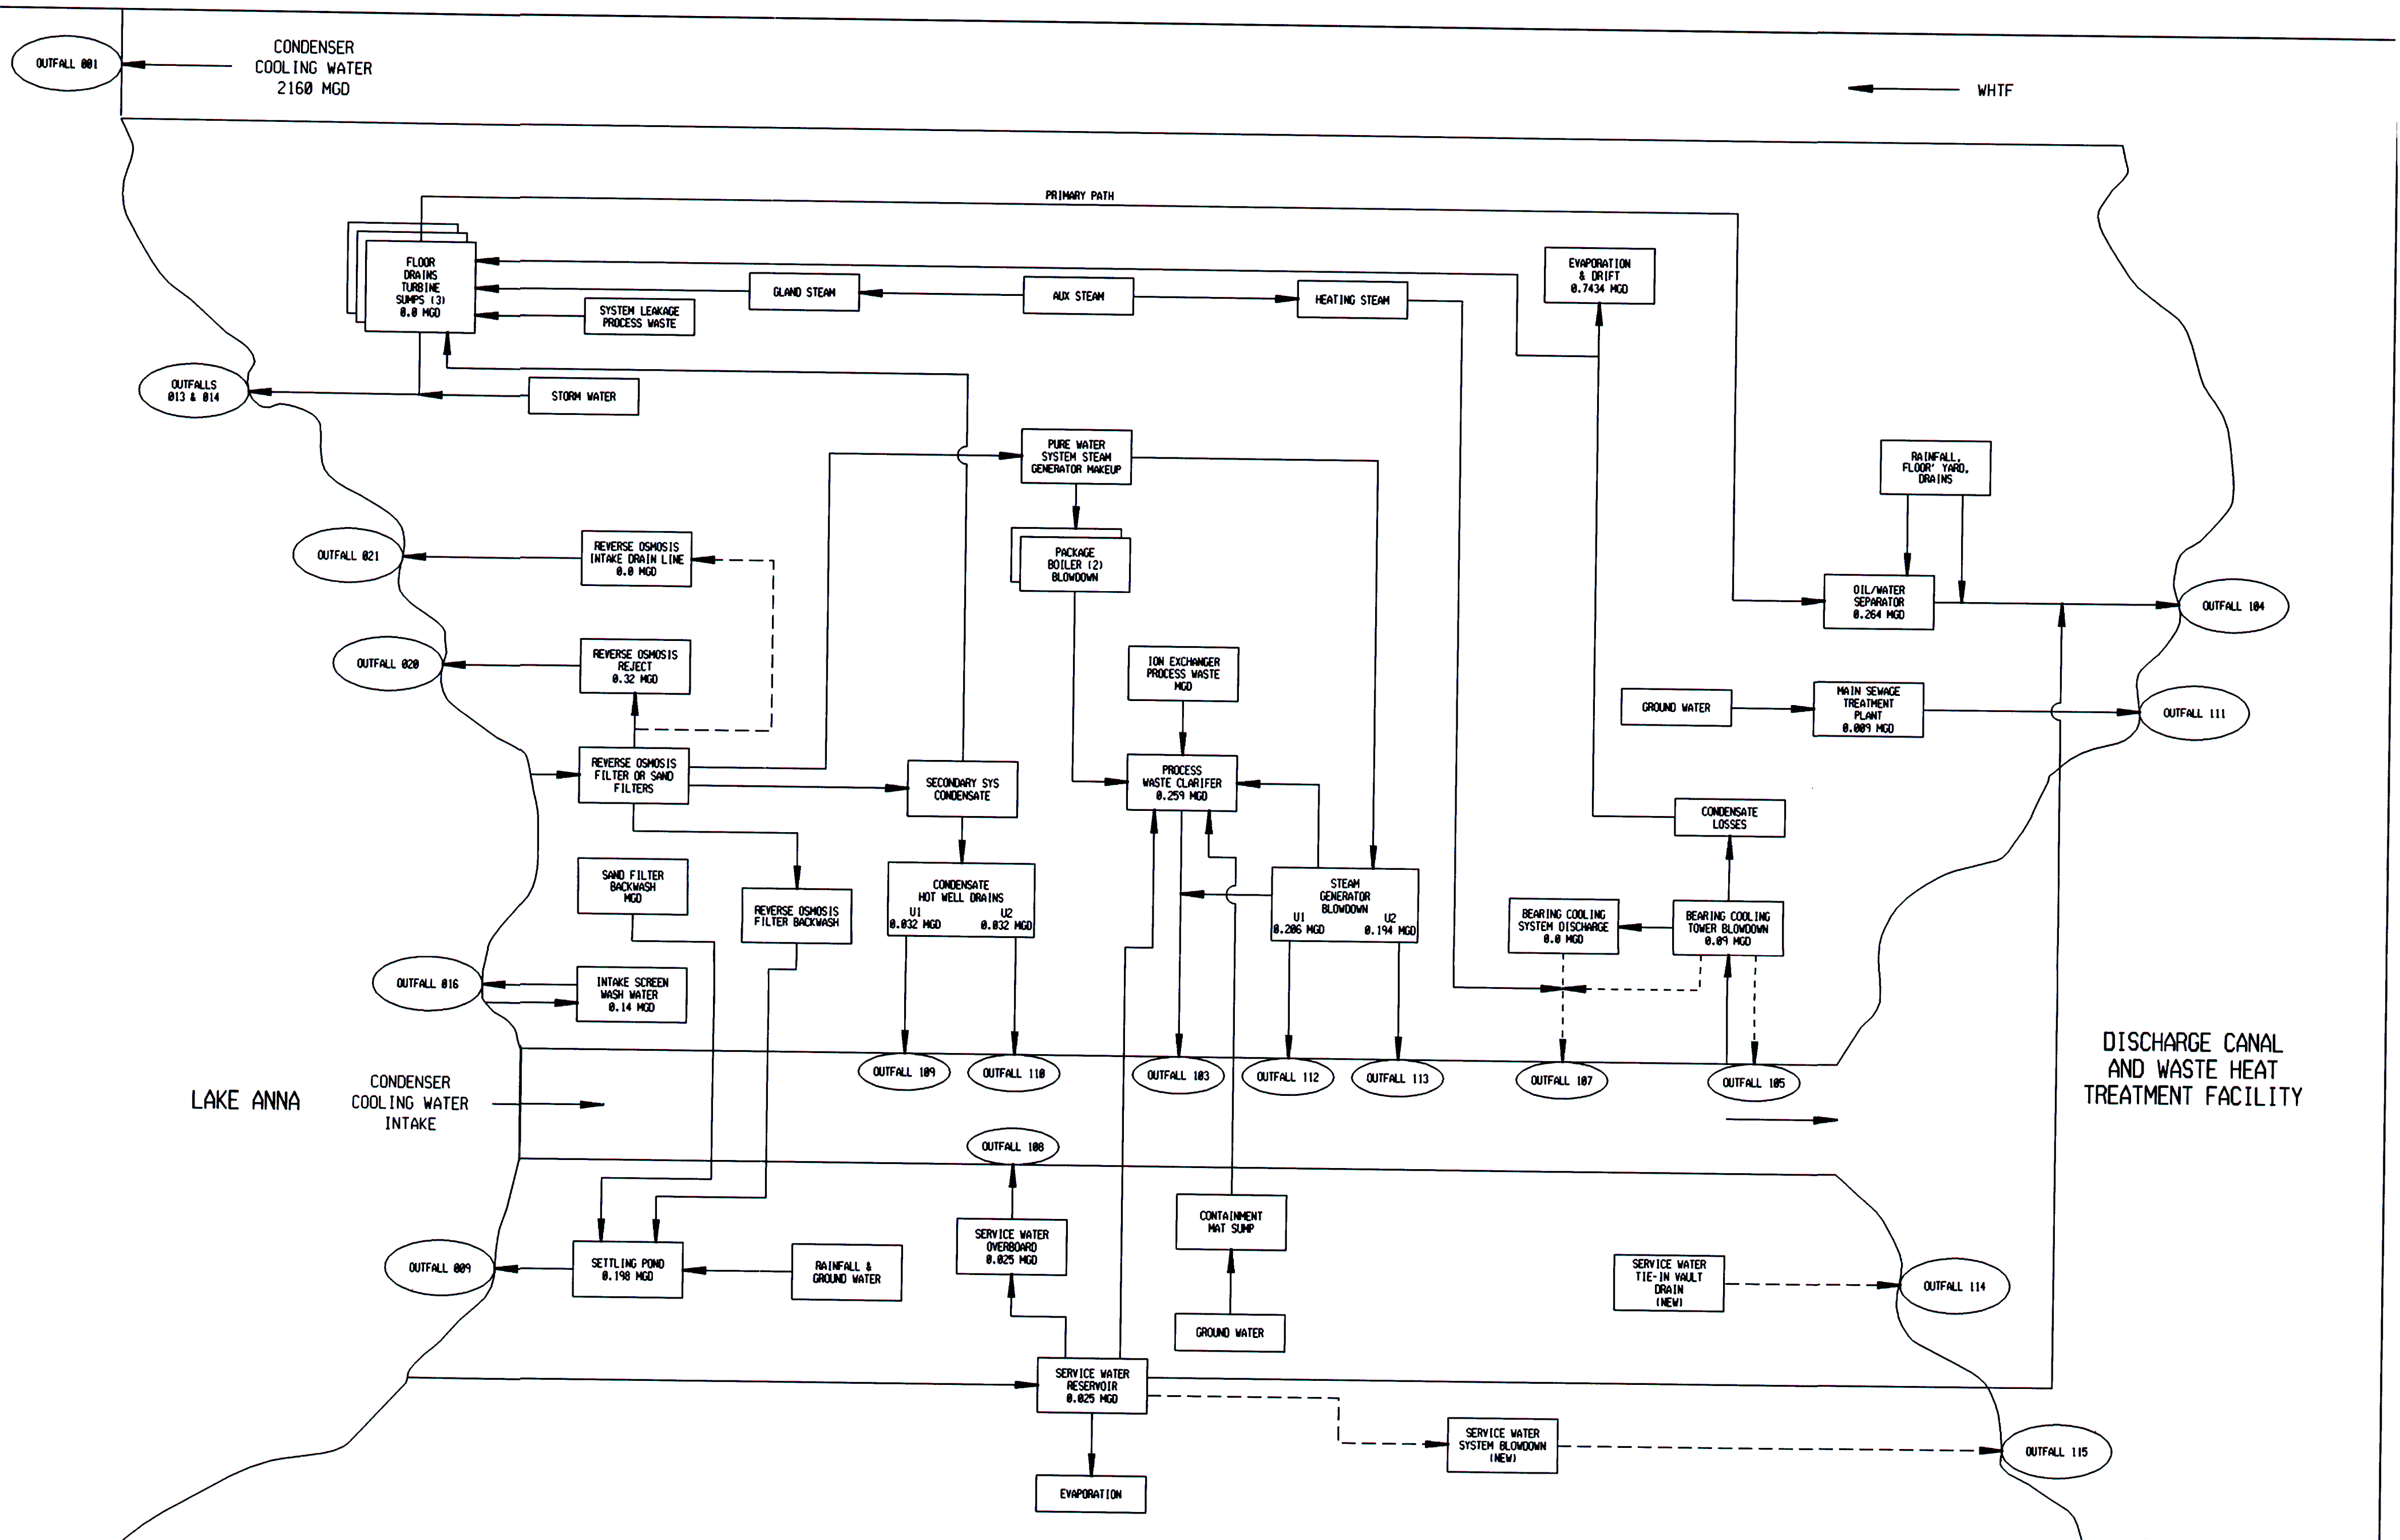



VIRGINIA POWER
NORTH CAROLINA POWER
 NUCLEAR ENGINEERING SERVICES
 RICHMOND, VIRGINIA

ONE LINE DIAGRAM
STATION WATER FLOW
NORTH ANNA POWER STATION

1	DELETED FLASH EVAPORATORS AND DOMESTIC WATER OVERFLOW (101, 102 & 109); ADDED SERVICE WATER PIPE VAULT DRAIN OVERFLOW (114)	DSGN	CHKD	ENGR	APPD	CAD NO: C:\usr\adgn\OUTFLOW20GNw31	DRAWING NO: NA-VPDES-083199-001	REV 1
REV	DATE	DSGN	CHKD	ENGR	APPD	SCALE:	UNLESS OTHERWISE NOTED SH 1 OF 1	

D-3